


- NOTES**
1. FOR MECHANICAL SYMBOLS AND GENERAL NOTES SEE DRAWING D-X-000-GEN-0002-M, 0003-M AND 0004-M.
 2. FOR HIGH POINT AND LOW POINT ROOF ELEVATIONS SEE ARCHITECTURAL DRAWING D-X-1300-GEN-0120-A.
 3. ALL EQUIPMENT TAG NUMBERS ARE SUFFIXED WITH "GSN" UNLESS OTHERWISE NOTED.

D-X-1300-GEN-0213-M

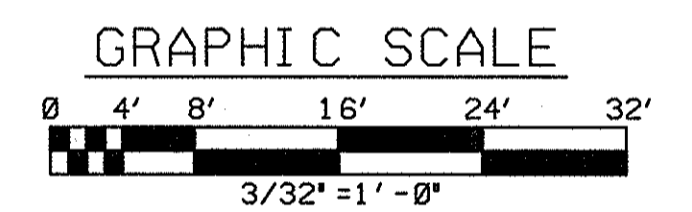

ROOF PLAN

U. S. DEPARTMENT OF ENERGY
PORTSMOUTH PADUCAH PROJECT OFFICE

UDS **BURNS AND ROE ENTERPRISES, INC.**
URANIUM DISPOSITION SERVICES, LLC Engineers and Constructors - Oradell, NJ
Ohio Certificate of Authorization No. 04-0247

BURNS AND ROE JOB NO. 2562 DOE CONTRACT NO. DE-AC05-02OR22717

PROJECT NAME
DEPLETED URANIUM HEXAFLUORIDE CONVERSION PROJECT

TITLE
**PORTSMOUTH DU_{F6} CONVERSION PROJECT
CONVERSION BUILDING
GENERAL ARRANGEMENT
ROOF PLAN**

EDCS CAD FILENAME DXI300GEN0208M.DGN	WBS IDENTIFICATION 1.02.02.01	BUILDING 1300	PLANT PORT	CLASS
SCALE 3/32" = 1' - 0"	TYPE DD	DRAWING NUMBER D-X-1300 - GEN - 0208 - M		REV 1

Engineering Review		
Disc	Engr	Date
Mech	EJT	6/8/05
Elec	HS	6/20/05
Civil	YC	7/6/05
Arch		
Instr		
Nuc		
Process		
Mat'l		

Drawn	Designed	Checked
EN	EN	MS

Lead Engineer	Date
R. PODESFINSKI	7/6/05

Approved by	
I. J. URZA	
Engineering/Design Mgr.	
Approved for Construction	
R. PODESFINSKI FOR R. NILAN	
Chief Mechanical Engineer	

Rev No	Revision	Date	Dwn	Chkd	Approved Chief Engr	Rev No	Revision	Date	Dwn	Chkd	Approved Chief Engr	Rev No	Revision	Date	Dwn	Chkd	Approved Chief Engr	Drawing Control					
1	REVISED: PER FINAL VENDOR EQUIPMENT DRAWING. 15 10/6/05 1/2 EJT	10/6/05	TK	MB	NEC														Purpose	Approved By	Date	Released By	Date
																			For Information				
																			For Comment				
																			For Bid				
																			For Fabrication				
																			For Construction				